




FRONT ELEVATION

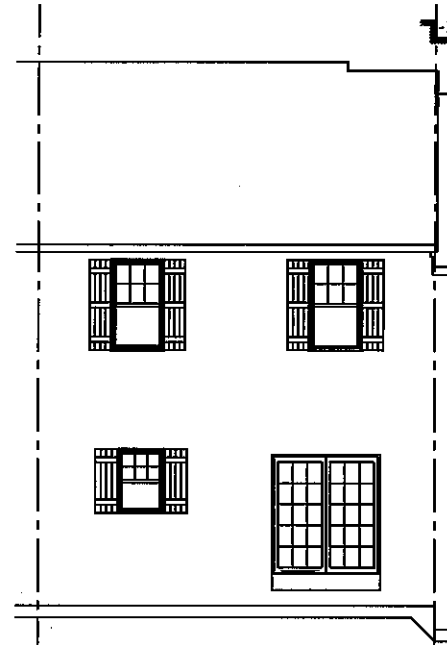

REAR ELEVATION

ALL AREA DIMENSIONS ARE APPROXIMATE. FLOOR PLANS AND ELEVATIONS MAY SHOW OPTIONAL ITEMS NOT INCLUDED WITH BASE PRICE. THE BUILDER RESERVES THE RIGHT TO IMPROVE THE PLANS BY REVISING THE SPECIFICATIONS AND DIMENSIONS WITHOUT NOTICE.

CLIENT 
CLIENT _____



WWW.GARMANBUILDERS.COM
P:(717) 733-4383 F:(717) 733-3225
"CREATORS OF
"BETTER HOMES"
LITTLE, PA 17543

These plans are the private property of Gorman Builders, Inc. Any use or reproduction of these plans, in part or whole, without the expressed written consent of Gorman Builders, Inc. is strictly prohibited.

...
Mayapple Towns Lot #7
DWC DESCRIPTION:
ELEVATIONS

DRAWN BY: JAS
DATE: 08/19/19
SCALE: 3/32" = 1'-0"
JOB NO.:
SQUARE FEET: 1,688
SHEET NO.: 2


ELECTRICAL LEGEND

	PHONE JACK
	CABLE JACK
	RECEPTACLE
	FLOOR RECEPTACLE
	RECESSED LIGHT
	CEILING FAN
	CEILING FAN ROUGH-IN
	SPOT LIGHT

CUSTOMER TO NOTE LOCATIONS OF STANDARD PHONE AND CABLE JACKS AS WELL AS ANY ADDITIONAL ITEMS PURCHASED ABOVE.

STANDARD OUTLET CONFIGURATION PER HOUSE
(2) PHONE OUTLETS
(3) CABLE OUTLETS
(5) TOTAL - CAN BE INTERCHANGED

****NOTE: WHEN A "STUDY" IS PRESENT AN ADDITIONAL PHONE AND CABLE OUTLET ARE INCLUDED FOR A TOTAL OF 7.**

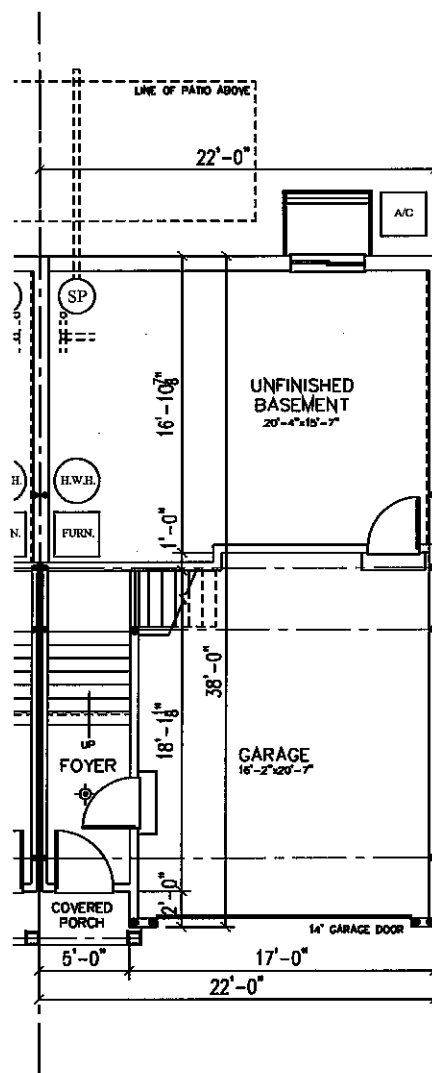

ALL AREA DIMENSIONS ARE APPROXIMATE. FLOOR PLANS AND ELEVATIONS MAY SHOW OPTIONAL ITEMS NOT INCLUDED WITH BASE PRICE. THE BUILDER RESERVES THE RIGHT TO IMPROVE THE PLANS BY REVISING THE SPECIFICATIONS AND DIMENSIONS WITHOUT NOTICE.

CLIENT 
CLIENT _____



WWW.GARMANBUILDERS.COM
P (717) 733-4383 F (717) 733-3225
"CREATORS OF
BETTER HOMES"
Lancaster, PA 17603

These plans are the private property of Garman Builders, Inc. May not be reproduced or these plans, in part or whole, without the expressed written consent of Garman Builders, Inc. is strictly prohibited.


Mayapple Towns Lot #7
FOUNDATION
SQUARE FEET: 104

DRAWN BY: JAS
DATE: 08/19/19
SCALE: 3/32" = 1'-0"
JOB NO.: MAT-007-27
SHEET NO: 3

	PHONE JACK
	CABLE JACK
	RECEPTACLE
	FLOOR RECEPTACLE
	RECESSED LIGHT
	CEILING FAN
	CEILING FAN ROUGH-IN
	SPOT LIGHT

STANDARD OUTLET CONFIGURATION PER HOUSE

- **NOTE: WHEN A "STUDY" IS PRESENT AN
ADDITIONAL PHONE AND CABLE OUTLET ARE
INCLUDED FOR A TOTAL OF 7.**

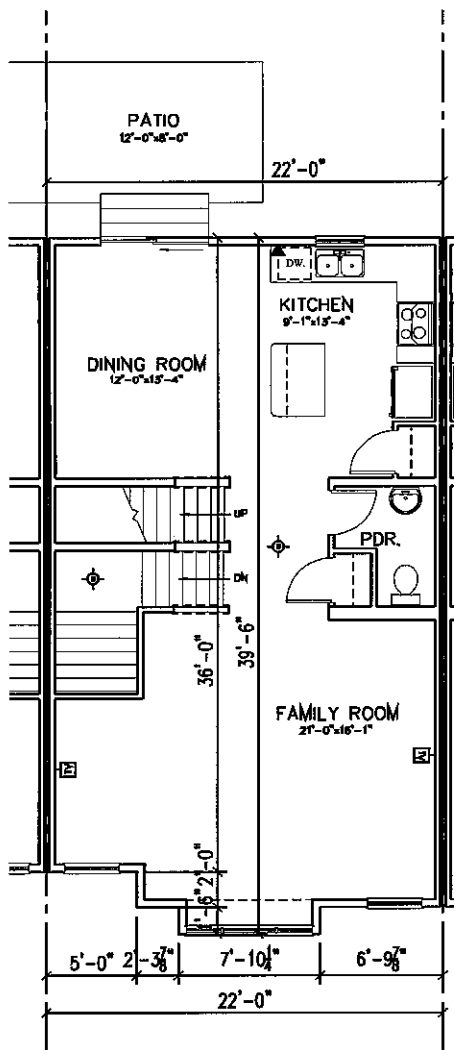

ALL AREA DIMENSIONS ARE APPROXIMATE. FLOOR PLANS AND ELEVATIONS MAY SHOW OPTIONAL ITEMS NOT INCLUDED WITH BASE PRICE. THE BUILDER RESERVES THE RIGHT TO IMPROVE THE PLANS BY REVISING THE SPECIFICATIONS AND DIMENSIONS WITHOUT NOTICE.

CLIENT

CLIENT

WWW.GARMANBUILDERS.COM
P: (717) 733-4383 F: (717) 733-3225

**"CREATORS OF
BETTER HOMES"**
Litz, PA 17543

These plans are the private property of Gorman Builders, Inc. Any use or reproduction of these plans, in part or whole without the expressed written consent of Gorman Builders, Inc. is strictly prohibited.

Mayapple Towns Lot #7

WQ. DESCRPTION:

WING. DESCRIPTION:
FIRST FLOOR

DRAWN BY JAS

DATE: 08/19/19

SCALE: 3/32" = 1'-0"

ON BOARD

HMN 18 030300

1300H
H.M.IA : 08 0207347

TOWNHOMES

776

ELECTRICAL LEGEND


	PHONE JACK
	CABLE JACK
	RECEPTACLE
	FLOOR RECEPTACLE
	RECESSED LIGHT
	CEILING FAN
	CEILING FAN ROUGH-IN
	SPOT LIGHT

CUSTOMER TO NOTE LOCATIONS OF STANDARD PHONE AND CABLE JACKS AS WELL AS ANY ADDITIONAL ITEMS PURCHASED ABOVE.

STANDARD OUTLET CONFIGURATION PER HOUSE

- (2) PHONE OUTLETS
- (3) CABLE OUTLETS
- (5) TOTAL - CAN BE INTERCHANGED

**NOTE: WHEN A "STUDY" IS PRESENT AN ADDITIONAL PHONE AND CABLE OUTLET ARE INCLUDED FOR A TOTAL OF 7.

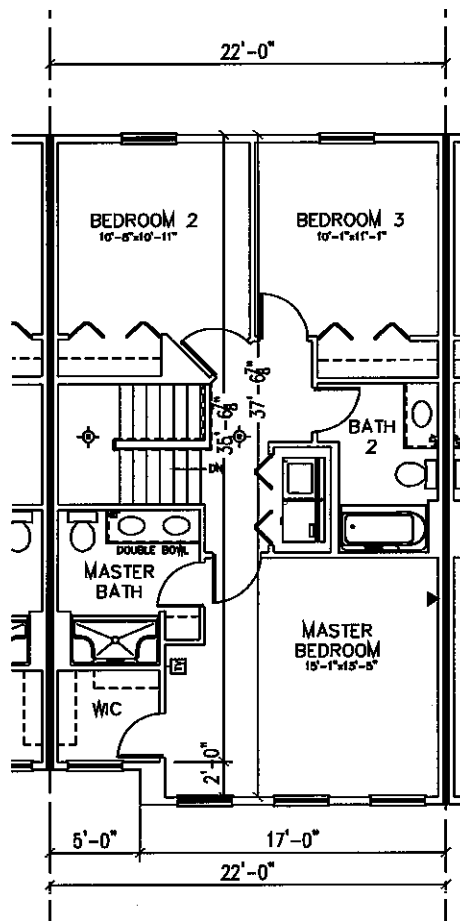

ALL AREA DIMENSIONS ARE APPROXIMATE. FLOOR PLANS AND ELEVATIONS MAY SHOW OPTIONAL ITEMS NOT INCLUDED WITH BASE PRICE. THE BUILDER RESERVES THE RIGHT TO IMPROVE THE PLANS BY REVISING THE SPECIFICATIONS AND DIMENSIONS WITHOUT NOTICE.

CLIENT

CLIENT

WWW.GARMANBUILDERS.COM
P:(717) 733-4383 F:(717) 733-3225



These plans are the private property of Garman Builders, Inc. Any reproduction of these plans in part or whole, without the expressed written consent of Garman Builders, Inc. is strictly prohibited.

Mayapple Towns Lot #7
SECOND FLOOR

DATE: 08/19/19
SCALE: 3/32" = 1'-0"
JOB NO.: MAT-007-27

CHECKED BY: MWH
TOWNHOMES
SHEET NO. 5